

# a Design for: SJS Group



Front  
Plan "AL"  
front elevation


SCALE: 1/4" = 1'-0"

NOTICE: This set of drawings for a custom designed home is the copyrighted property of SULLIVAN HENRY OGGERO & ASSOCIATES, INC. This single copy is licensed pursuant to the terms and conditions of the Plan License Agreement and no right to reproduce, copy or duplicate all or any portion of the licensed plans is granted, either expressly or implied.



Acceptance of this single copy of the set of plans constitutes an acknowledgement of the duties and obligations of the Plan License Agreement of SULLIVAN HENRY OGGERO & ASSOCIATES, INC.

ALL IDEAS, DESIGNS, ARRANGEMENTS AND PLANS INDICATED OR REPRESENTED BY THE DRAWINGS ARE OWNED BY THE PROPERTY OF THE DESIGNERS AND WERE CREATED, EVOLVED AND DEVELOPED FOR USE ON AND IN CONNECTION WITH THE SPECIFIED PROJECT. NONE OF THE SKETCHES, DESIGNS, ARRANGEMENTS OR PLANS SHALL BE USED BY OR DISCLOSED TO ANY PERSON, FIRM OR CORPORATION FOR ANY PURPOSE WHATSOEVER WITHOUT THE WRITTEN PERMISSION OF THE DESIGNERS. WRITTEN DIMENSIONS ON THESE DRAWINGS SHALL HAVE PRECEDENCE OVER SCALED DIMENSIONS. CONTRACTORS SHALL VERIFY AND BE RESPONSIBLE FOR ALL DIMENSIONS AND CONDITIONS ON THE JOB, AND THIS OFFICE MUST BE NOTIFIED OF ANY VARIATIONS FROM THE DIMENSIONS AND CONDITIONS SHOWN ON THESE DRAWINGS.

© COPYRIGHT 2019 SULLIVAN HENRY OGGERO & ASSOC., INC.

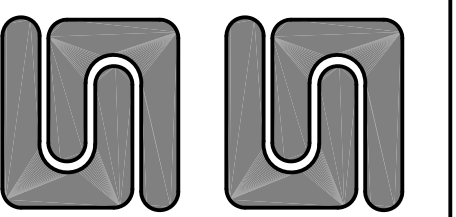



*Sullivan  
Henry  
Oggero*

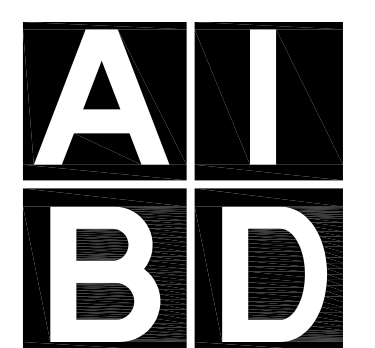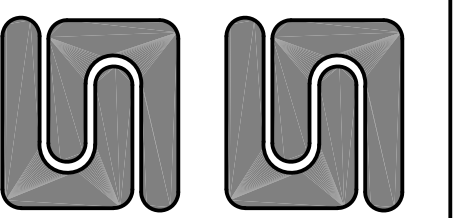



unless otherwise noted

CHECK SET  
NOT FOR CONSTRUCTION

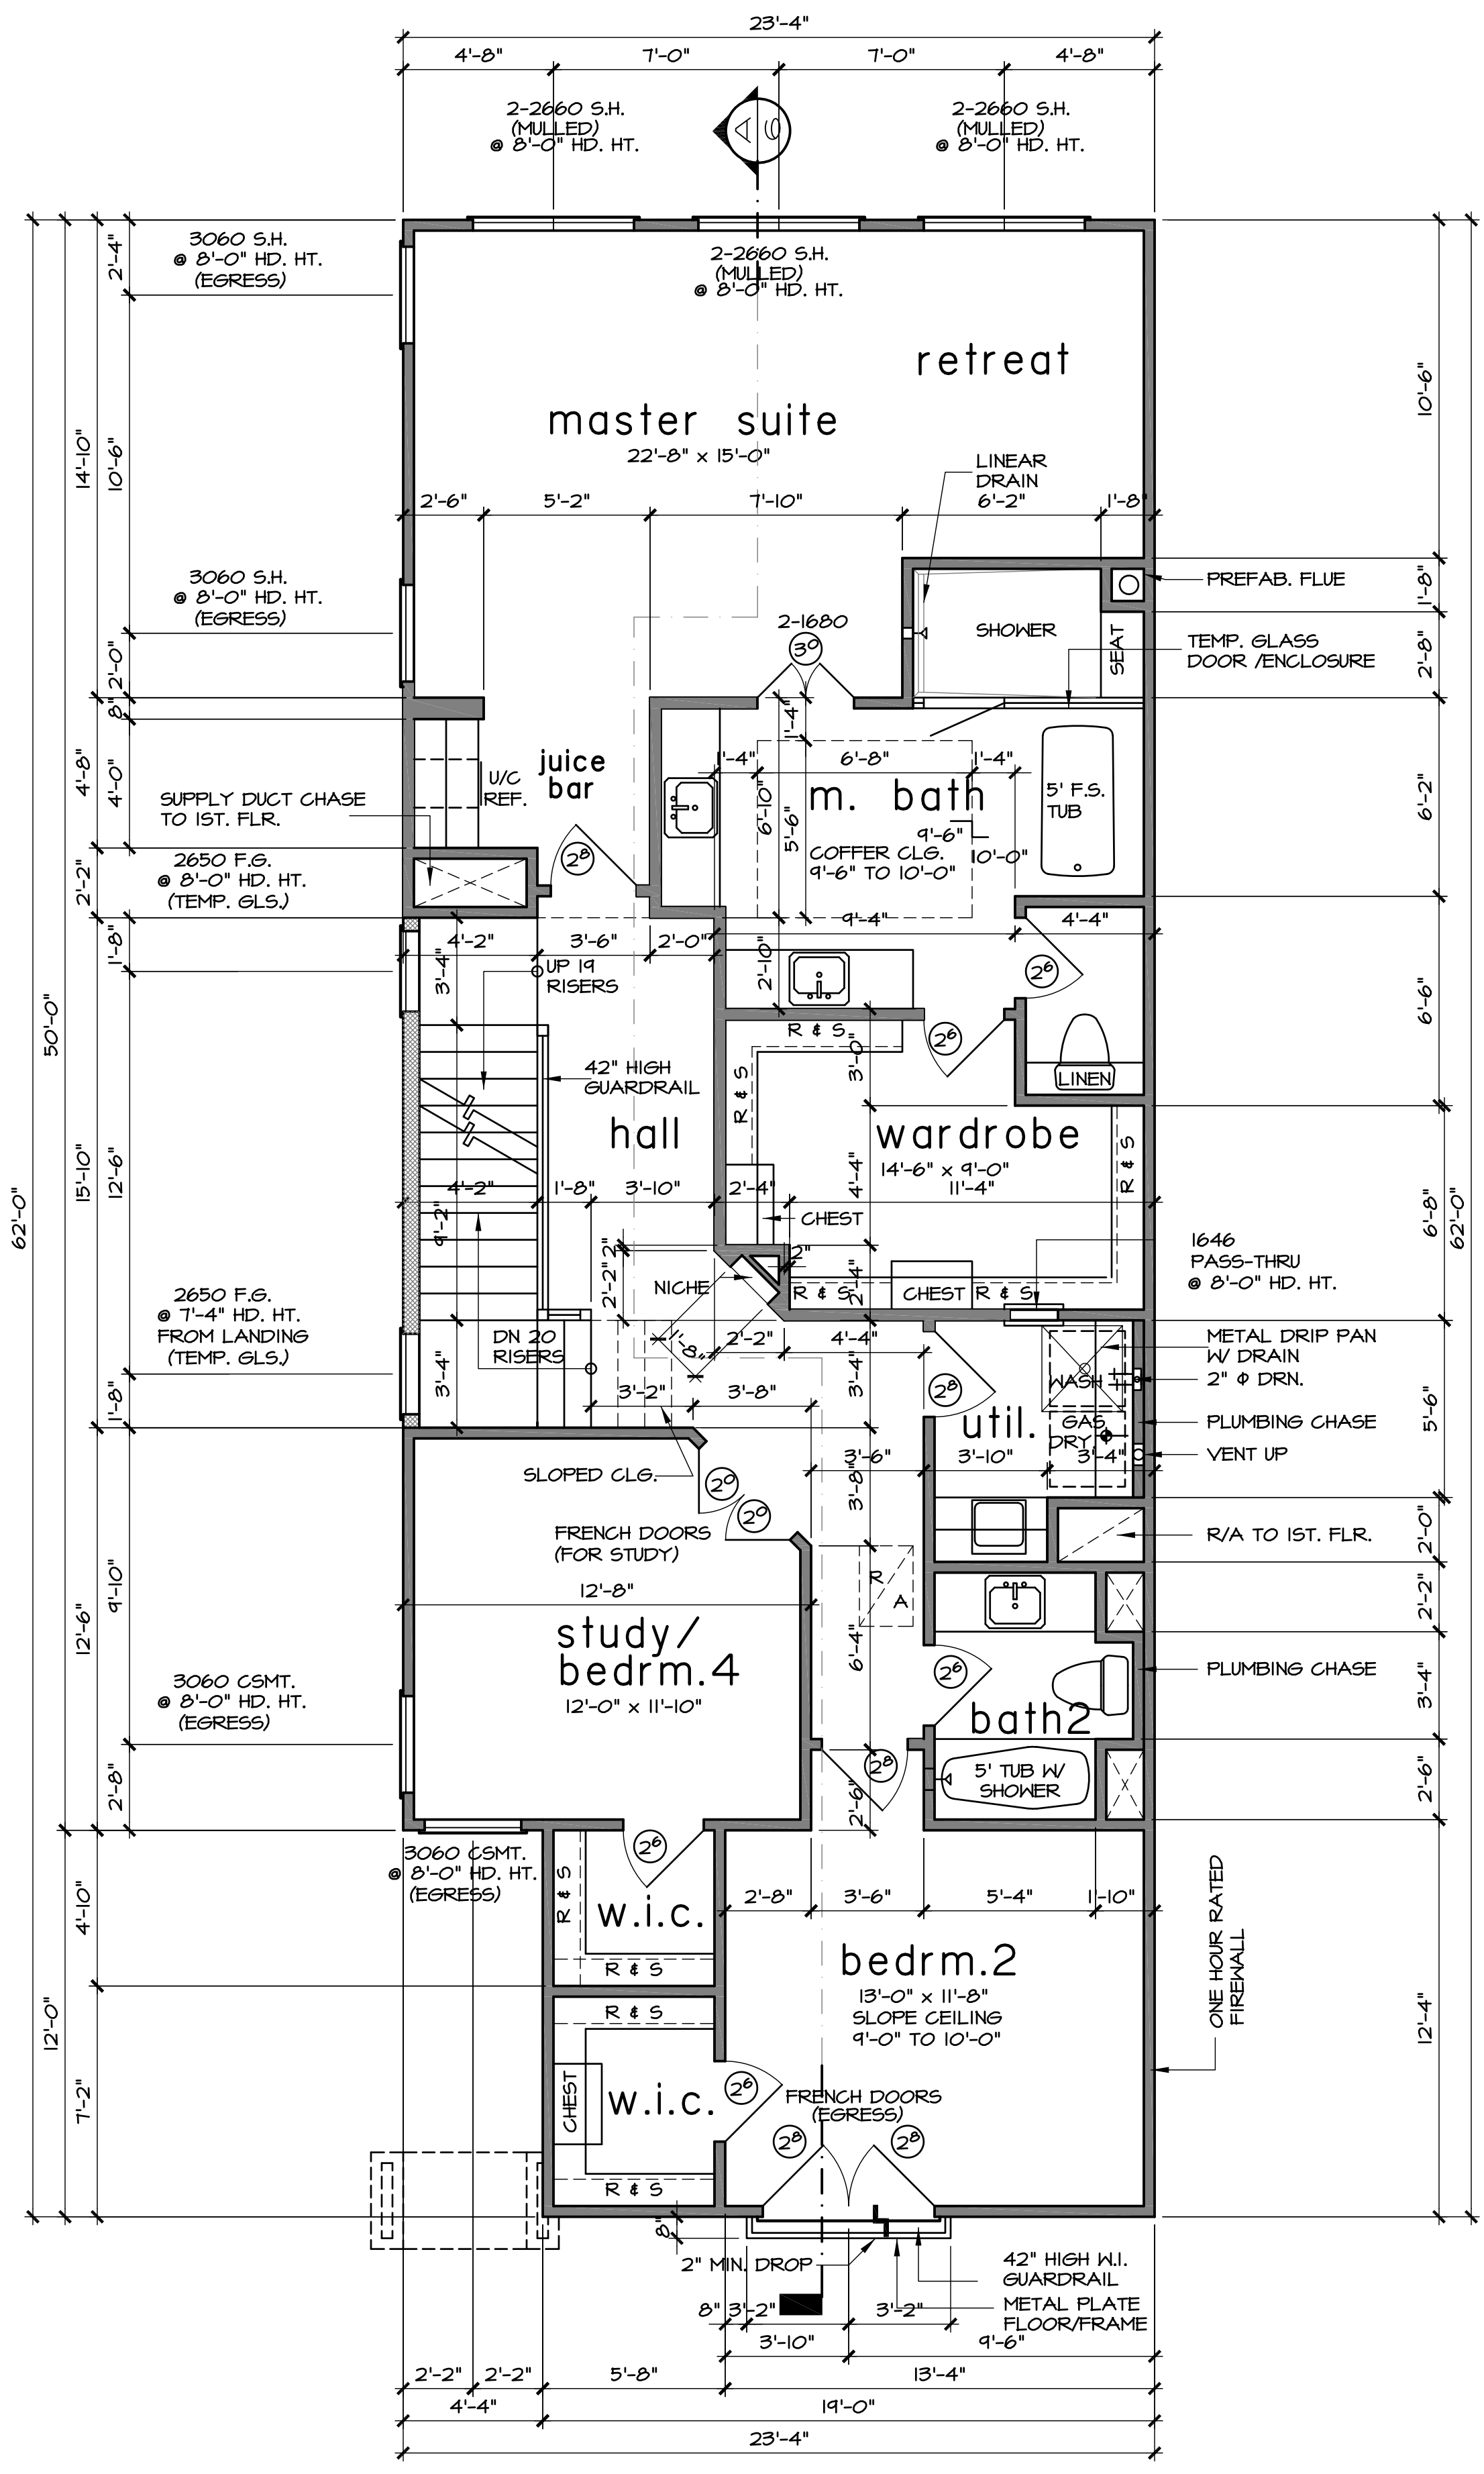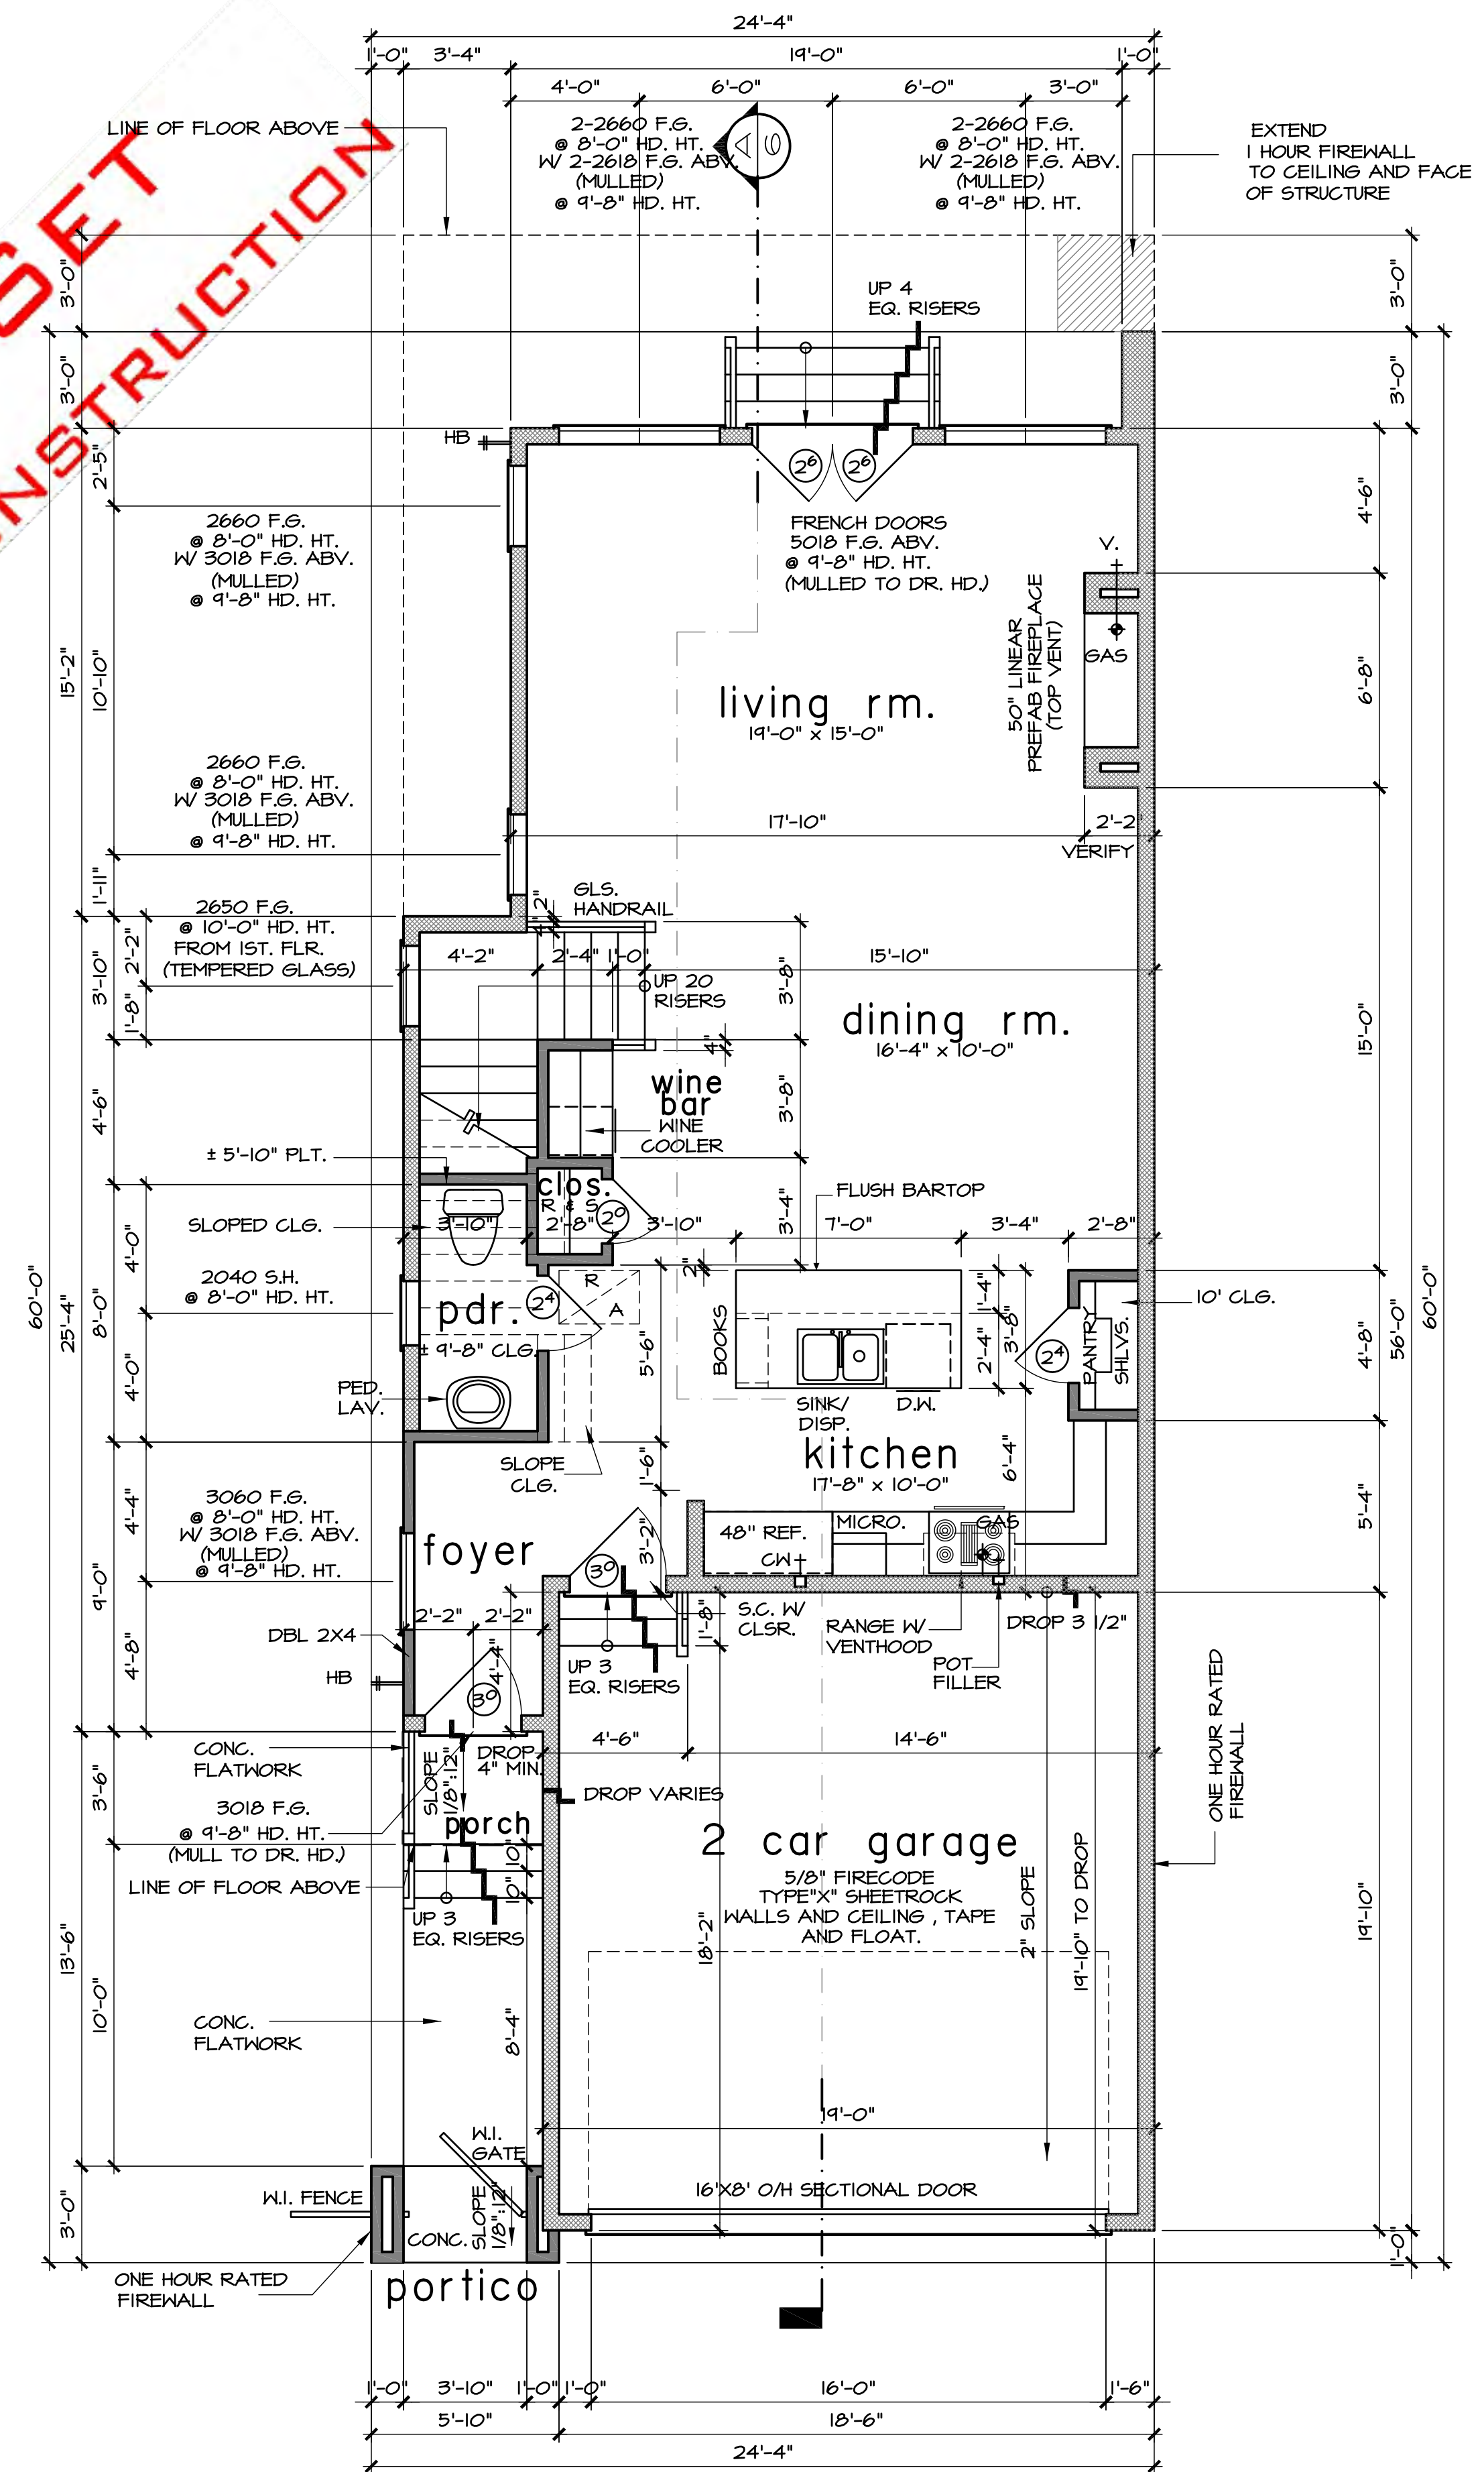

- GYP. BOARD WALLS AND CEILING
- 11'-0" CLG. HT. AT FIRST FLOOR
- 10'-0" CLG. HT. AT SECOND FLOOR
- 9'-0" CLG. HT. AT THIRD FLOOR
- ALL ANGLES TO BE 45 DEGREES
- 1/4" SQ. DOORS
- 8'-0" DOOR HT. AT FIRST FLR.
- 8'-0" DOOR HT. AT SECOND FLR.
- 8'-0" DOOR HT. AT THIRD FLR.
- SINGLE HUNG ALUMINUM WINDOWS WITH DIVIDED LTS.
- 8'-0" HEADER HT. AT FIRST FLR.
- 8'-0" HEADER HT. AT SECOND FLR.
- 7'-0" HEADER HT. AT THIRD FLR.
- ALL BEDROOM WINDOWS TO BE 44" A.F.F. (MAX)
- 24" HIGH X 20" WIDE (MIN.) OPENING WITH 5.7 SQ. FT. (MIN.) NET CLEAR OPENING WHEN DOORS ARE USED FOR EMERGENCY EGRESS, IT SHALL BE OPERATIONAL FROM THE INSIDE WITHOUT THE USE OF KEYS OR TOOLS.
- ALL BEDROOM WDN @ 2ND FLR. TO BE MIN. 24" A.F.F.
- ALL GLAZING WITHIN HAZARDOUS LOCATIONS SHALL HAVE SAFETY GLASS IN COMPLIANCE WITH R308 (IRC 2012)
- ALL EGRESS DOORS & WINDOWS SHALL HAVE LOCKS ALLOWING EGRESS WITHOUT THE USE OF A KEY AND MEET R310 & 311.
- SMOKE DETECTORS REQUIRE 110V CONNECTION TO HOUSE WIRING AND BATTERY BACKUP. LOCATIONS TO COMPLY WITH R314 (IRC 2012). MULTIPLE UNITS SHALL BE 2012 INTERCONNECTED TO ACTIVATE ALL ALARMS. CONSULT MANUF. RECOMMENDATIONS FOR DISTANCE FROM R/A.
- LOCATE GAS WATER HEATER IN ATTIC ABV. LOAD BEARING PARTITION IN PAN WITH RELIEF DRAIN LINE TO OUTSIDE, INSTALLATION MUST COMPLY WITH MANUF. INSTRUCT. AND ALL APPL. CODES.
- PROVIDE VENTILATION AT ALL BATHS AND UTILITY ROOMS THROUGH NATURAL OR MECH. MEANS AND COMPLY WITH R303 & M507 (IRC 2012)
- CHIMNEYS TO BE 3'-0" MIN. ABV. THE HIGHEST POINT WHERE THEY PASS THROUGH THE ROOF AND AT LEAST 2'-0" MIN. HIGHER THAN ANY PORTION OF THE ROOF WITHIN A 10'-0" RADIUS
- ALL PREFAB FIREPLACES TO BE UL & IRC 2012 APPROVED & A COPY OF THE MANUF. INSTALLATION MANUAL SHALL BE AVAILABLE @ JOB SITE FOR INSPECTOR'S REVIEW
- A CARBON MONOXIDE DETECTOR SHALL BE INSTALLED IN BEDROOMS WHEN A GAS FIREPLACE IS INSTALLED AND OUTSIDE EACH SEPARATE SLEEPING AREA IN THE IMMEDIATE VICINITY OF THE BEDROOMS WHICH FUEL-FIRED APPLIANCES ARE INSTALLED & OR HAVE ATTACHED GARAGES.
- STAIRWAYS SHALL COMPLY WITH R311 (IRC 2012) SEE DETAIL SHT.
- SAFETY TERMINAL ADJACENT TO THE WALL ALLOW 2" MIN. BTWN WALL & RAIL R 311.1.2.
- ALL GUARDRAILS AND HANDRAILS SHALL COMPLY WITH R311 & R301.5 (IRC 2012). THE MIN UNIFORM LIVE LOAD SHALL BE 200# AND A SINGLE CONCENTRATED LOAD APPLIED IN ANY DIRECTION AT ANY POINT ALONG THE TOP
- GUARDRAILS TO BE 36" A.F.F. (MIN) WITH BALUSTERS AT 4" O.C. MAX. PER R311 & 312 (IRC 2012) SEE DETAIL SHT.
- THE TRIANGULAR OPENINGS FORMED BY THE RISER, TREAD AND BOTTOM RAIL OF A GUARD AT THE OPEN SIDE OF A STAIRWAY ARE PERMITTED TO BE OF SUCH A SIZE THAT A SPHERE 6 INCHES (152 mm) CANNOT PASS THROUGH.
- HANDGRIPPING PORTION OF HANDRAILS SHALL BE NOT LESS THAN 1 1/4" NOT MORE THAN 2" IN CROSS SECTIONAL DIMENSION OR THE SHAPE SHALL PROVIDE AND EQUIV. GRIPPING SURFACE PER R311 (IRC 2012).
- ENCLOSE UNDERSIDE OF STAIRWELL WITH 5/8" TYPE "X" FIRE CODE GYP. BOARD
- SIZE AND NUMBER OF NAILS CONNECTING WOOD MEMBERS SHALL COMPLY WITH IRC 2012 TABLE R602.3 (1) & (2) (OR EQ.) REFER TO STANDARD DETAIL SHEET
- DISAPPEARING STAIRS TO BE MIN. 22" X 30" CLEAR OPENING (30" X 54" ROJ) & SHALL COMPLY WITH R307 (IRC 2012). INDIVIDUAL STAIR TREADS SHALL BE DESIGNED FOR UNIFORMLY DISTRIBUTED LIVE LOAD OR A 350 LB CONCENTRATED LOAD ACTING OVER AN AREA OF 4 SQ. INCHES, WHICHEVER PRODUCES THE GREATEST STRESS
- ATTIC ACCESS/DISAPPEARING STAIRS IN THE GARAGE CLG. MAY BE INSTALLED PROVIDED THE EXPOSED PANEL IS NOT LESS THAN 3/8" THICK FIRE RETARDANT TREATED PLYWOOD, 1/2" SHEET ROCK OR COVERED W/ A MIN. OF 16ga SHEET METAL. ROUGH OPENING SHALL NOT BE LESS THAN 22" X 30" AS PER IRC 2012 SECTION R307.1.
- ALL HEIGHTS ARE DEFINED FROM MAIN FINISHED FLOOR.
- SLOPE 1/8" PER EVERY 1'-0" TYP. AT PORCH, PAVILION, ETC.

**bath schedule**

- TILE FLOORS (AT WET AREAS)
- TILE WALLS AT TUB (SECONDARY BATHS)
- TILE FULL AT SHOWER
- SOLID SURFACE COUNTER TOPS AND SPLASHES
- ALL GLASS AT TUBS AND SHOWERS SHALL BE TEMPERED
- SAFETY GLASS AND MUST COMPLY WITH R308 (IRC 2012)
- SHOWER STALLS AND TUB (WITH SHOWER HEADS) WALLS TO BE FINISHED WITH NON ABSORBENT SURFACE TO A HT. OF NOT LESS THAN 72" ABV. DRAIN INLET OVER CONCRETE BACKERBOARD R307.2.
- ALL PLUMBING FIXTURES SHALL BE SPACED PER R307.1 (IRC 2012)

**square footage:**

FIRST FLOOR	801	SQ. FT.
SECOND FLOOR	1395	SQ. FT.
THIRD FLOOR	873	SQ. FT.
<b>TOTAL LIVING AREA</b>	<b>3069</b>	<b>SQ. FT.</b>
GARAGE	374	SQ. FT.
PORTICO	16	SQ. FT.
MECH	146	SQ. FT.
COVERED ROOF TERRACE	38	SQ. FT.
<b>TOTAL COVERED AREA</b>	<b>3643</b>	<b>SQ. FT.</b>
UNCOVERED ROOF TERRACE	114	SQ. FT.

**floor plans**

SCALE: 1/4" = 1'-0"


**Front Plan "AL"**

PLAN NO.	3064-AL	SHEET NO.	2 OF 9
----------	---------	-----------	--------

SULLIVAN HENRY OSSGERO & ASSOC., INC. IS A PROFESSIONAL BUILDING DESIGN FIRM. IT IS NOT AN ENGINEERING FIRM. WE ARE NOT QUALIFIED TO NOR LICENSED TO DESIGN STRUCTURAL FRAMING OR FOUNDATIONS. A LICENSED PROFESSIONAL ENGINEER SHOULD BE CONSULTED REGARDING THE FRAMING AND FOUNDATION. SHOULD AN ENGINEER'S SEAL BE PRESENT ON THESE DRAWINGS, THE ENGINEER OF RECORD SHALL BEAR THE RESPONSIBILITY FOR THE STRUCTURAL DESIGN. SULLIVAN HENRY OSSGERO & ASSOC., INC. WILL NOT BE HELD RESPONSIBLE FOR THE STRUCTURAL DESIGN IN ANY WAY AND/OR ANY PROBLEMS WHICH MAY ARISE.

1900099 REF: 140405 11.6.2014  
 F:\Builder's Archives\SLS Group\2019\1900099\FRONT UNITS\FRONT-left entry ALL2-1900099-FRONT-left A-F1-F2.dwg, 11/5/2019 3:48:07 PM



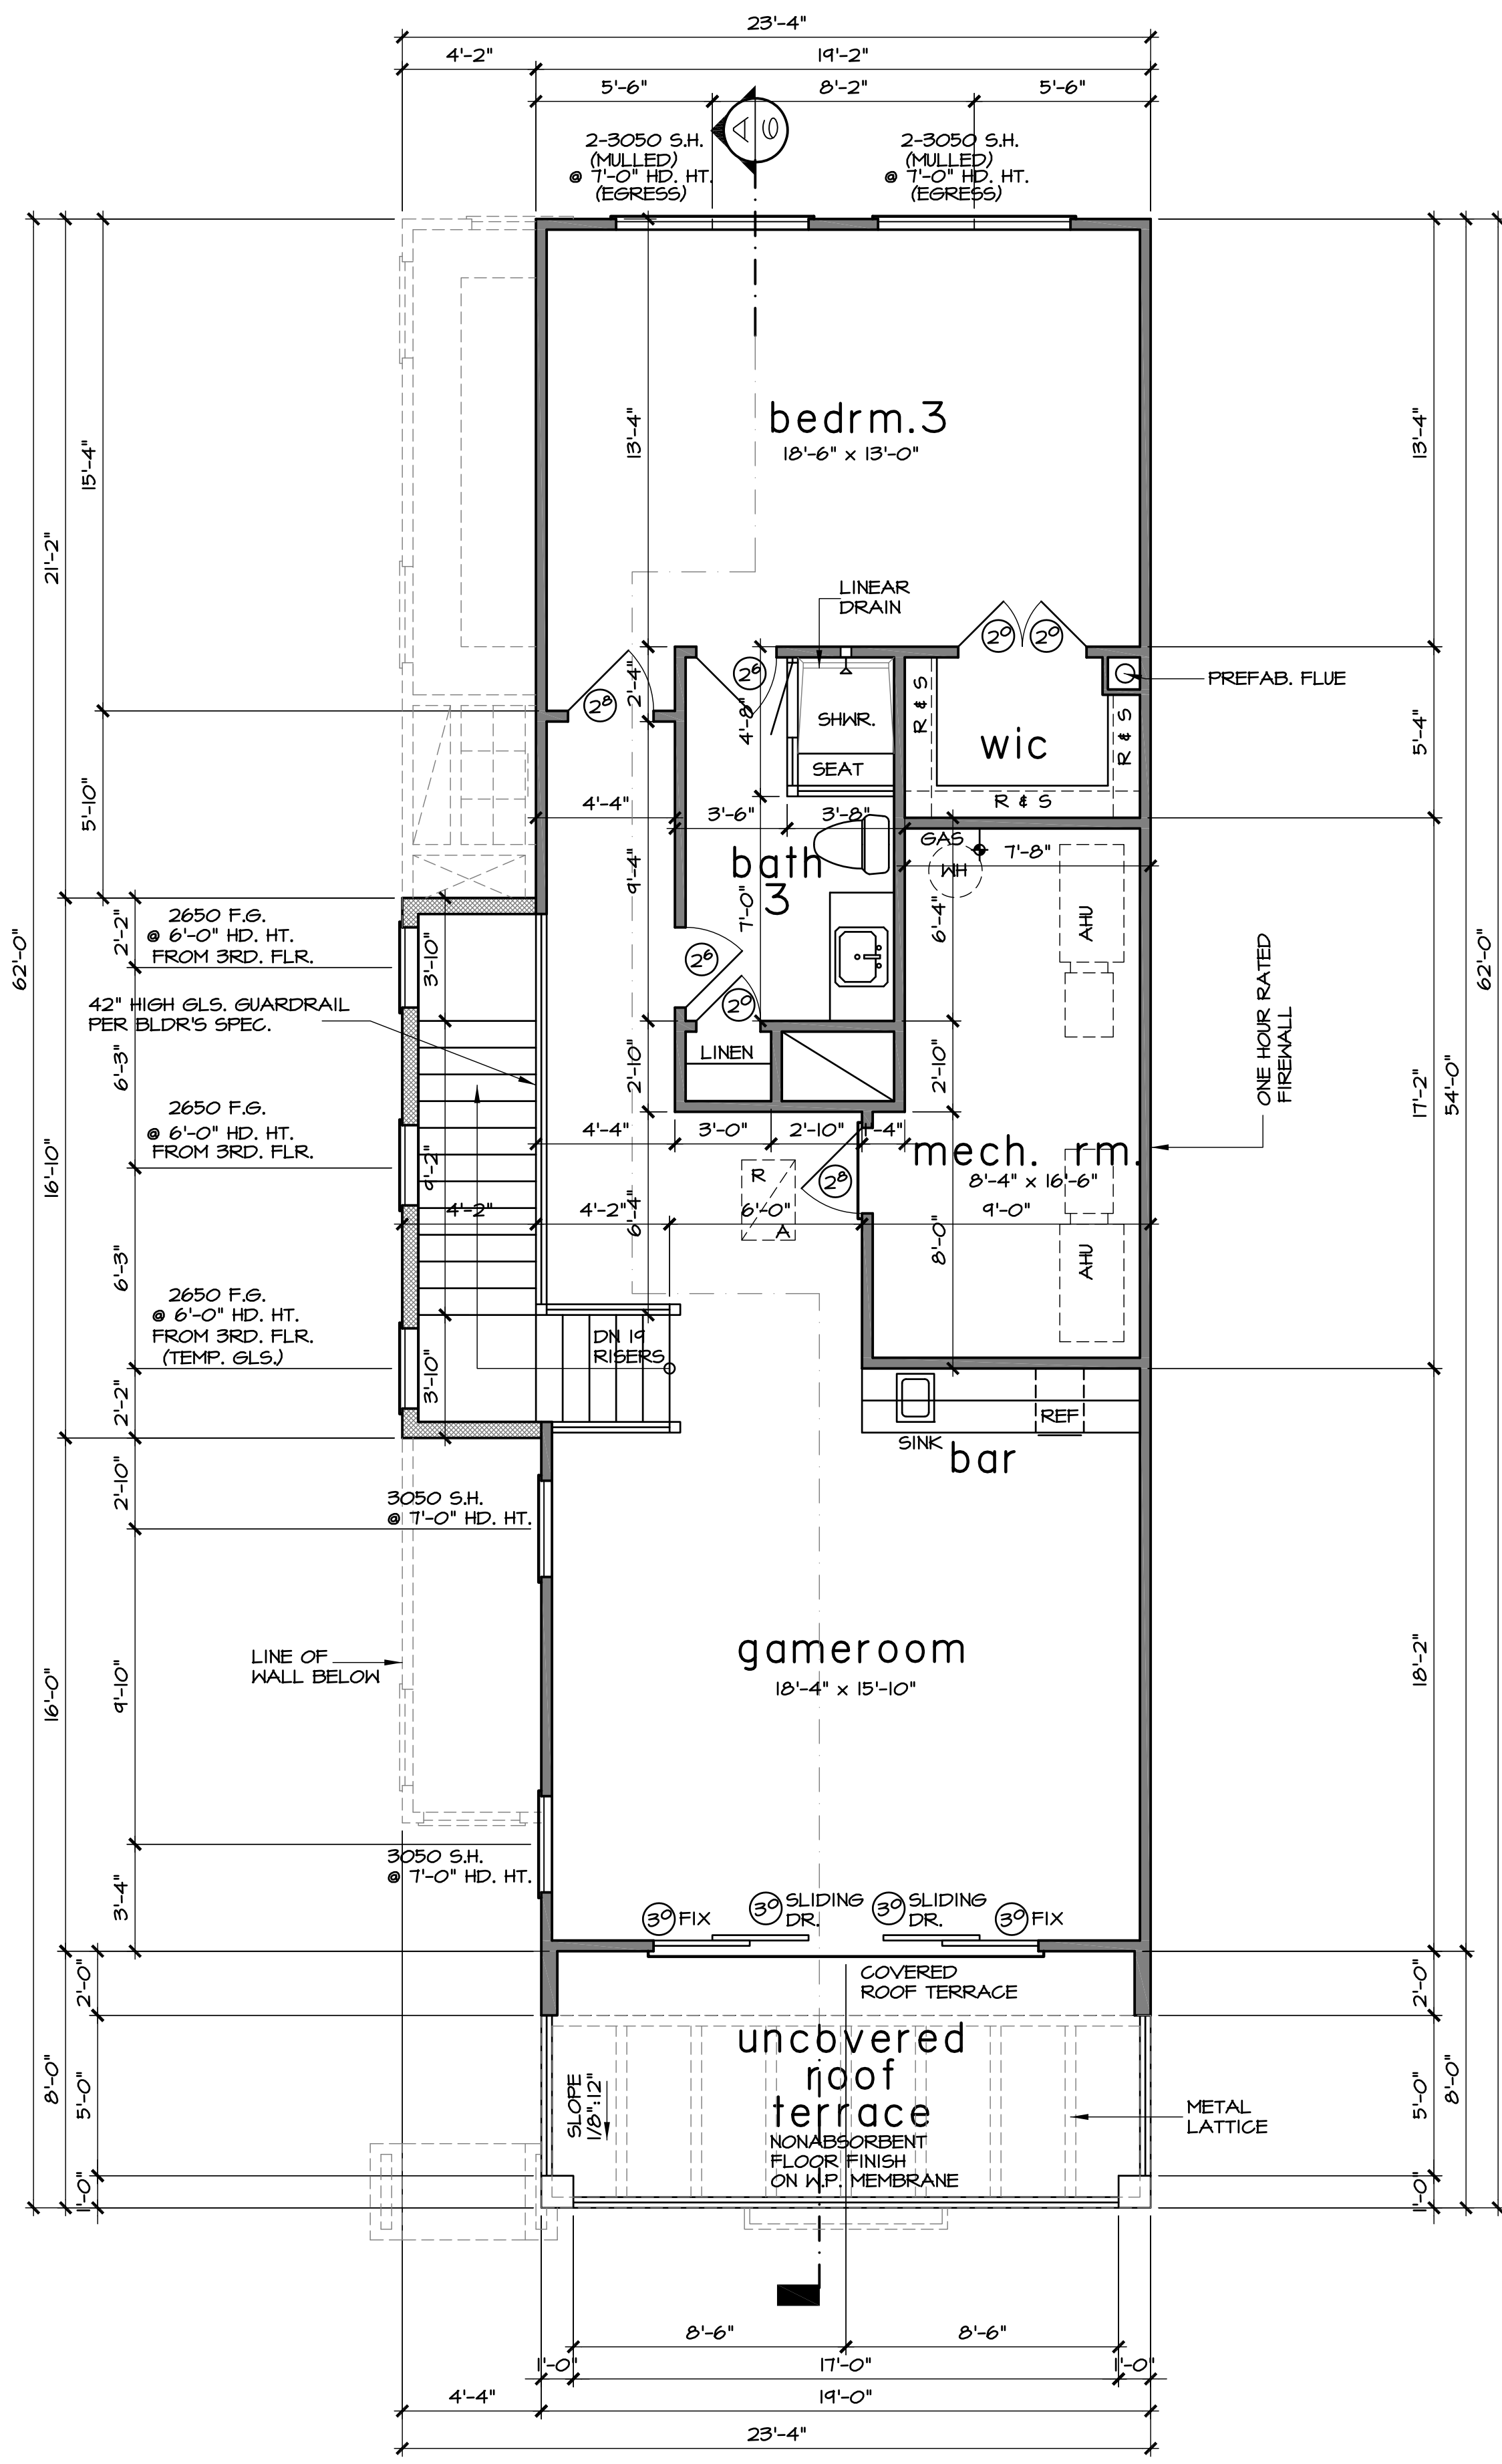

third floor plan (9'-0" CLG.)

SCALE: 1/4" = 1'-0"

**CHECK SET**  
**NOT FOR CONSTRUCTION**

third floor and roof plan

SCALE: 1/4" = 1'-0"

Front Plan "AL"

PLAN NO. 3064-AL	SHEET NO. 3 OF 4
------------------	------------------